


LEGEND			
⊕	SWITCH	TV	TELEVISION
⊕ <sub>3</sub>	3 WAY SWITCH	⊕	120V RECEPTACLE
⊕ <sub>4</sub>	4 WAY SWITCH	⊕	120V SWITCHED RECEPTACLE
⊗	CEILING FIXTURE OUTLET	⊕	220V RECEPTACLE
⊕ <sub>K</sub>	KEY LIST	⊕ <sub>GFI</sub>	GFI OUTLET
⊕ <sub>MP</sub>	WALL MOUNT FIXTURE	⊕ <sub>MP</sub>	GFI/WATERPROOF OUTLET
⊕	RECESSED LIGHT	⊕ <sub>GL</sub>	GAS LINE
⊕ <sub>SL</sub>	RECESSED LIGHT IN SLOPE	⊕ <sub>WL</sub>	WATER LINE
CH	CHIMES	⊕ <sub>HB</sub>	HOSE BIBB
PH	TELEPHONE	⊕	FLOOD LIGHT
SD	SMOKE DETECTOR	⊕	N4 LIMINOUS FIXTURE
SO	SECURITY OUTLET	⊕	CEILING FAN
□	GARAGE DOOR OPENER	---	ELECTRICAL WIRING
⊕	EXHAUST FAN	TV/PH	TELEVISION + PHONE OUTLET
KP	SECURITY KEYPAD		

ELECTRICAL PLANS TO FOLLOW ALL LOCAL CODES

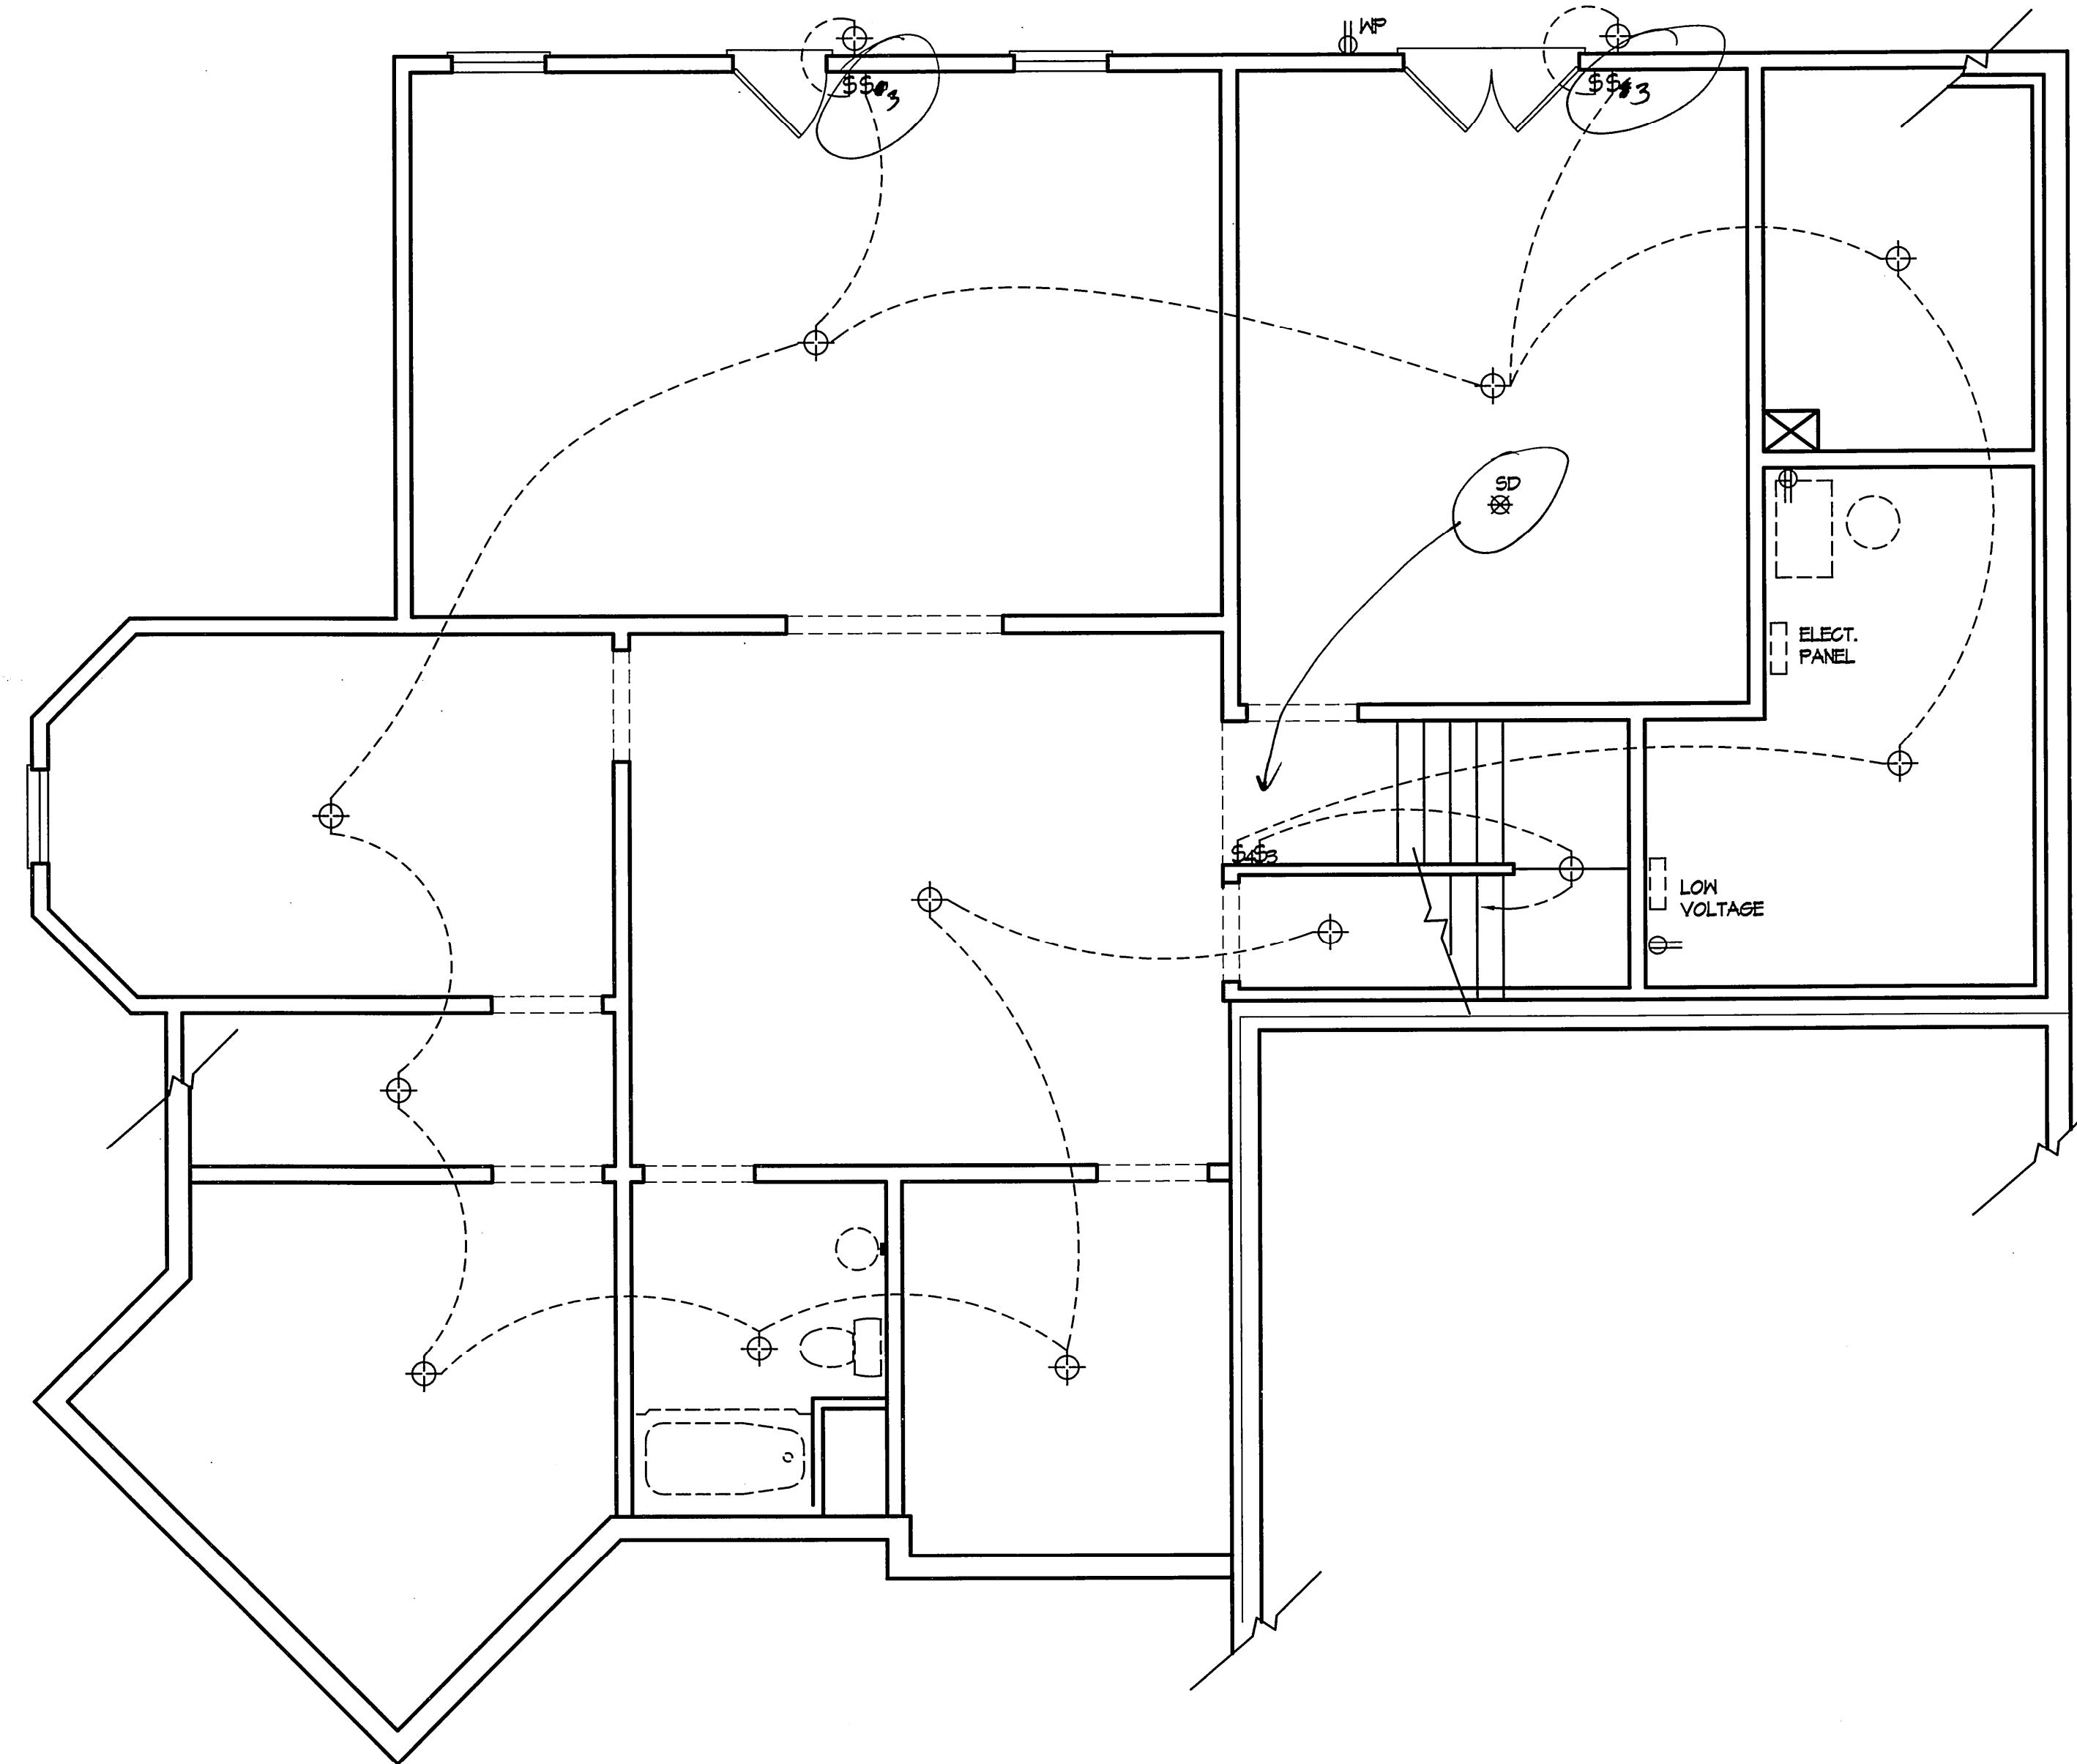

**BASEMENT LEVEL ELECTRICAL PLAN**  
SCALE: 1/4" = 1'-0"

**THE "BEECHWOOD"**  
FRONT ELEVATION & DETAILS

ORIGINAL DESIGN BY:  
STREET SCAPES  
107 WEST COLUMBIA SQUARE SUITE 205  
COLUMBIA, GA 30046

Revision:	Date:
-	-

Comm. No. 0504  
Dr. By: JKL  
Date: 9/19/05  
Sheet: