


LEGEND			
\$	SWITCH	TV	TELEVISION
\$3	3 WAY SWITCH	⊕	120V RECEPTACLE
\$4	4 WAY SWITCH	⊕	120V SWITCHED RECEPTACLE
⊗	CEILING FIXTURE OUTLET	⊕	220V RECEPTACLE
⊕	KEY LIST	⊕	GFI OUTLET
⊕	WALL MOUNT FIXTURE	⊕	GFI/WATERPROOF OUTLET
⊕	RECESSED LIGHT	†GL	GAS LINE
⊕	RECESSED LIGHT IN SLOPE	†WL	WATER LINE
CH	CHIMES	†HB	HOSE BIBB
PH	TELEPHONE	⊕	FLOOD LIGHT
SD	SMOKE DETECTOR	⊕	1/4 LUMINOUS FIXTURE
SO	SECURITY OUTLET	⊕	CEILING FAN
□	GARAGE DOOR OPENER	---	ELECTRICAL WIRING
⊕	EXHAUST FAN		

ELECTRICAL PLANS TO FOLLOW ALL LOCAL CODES

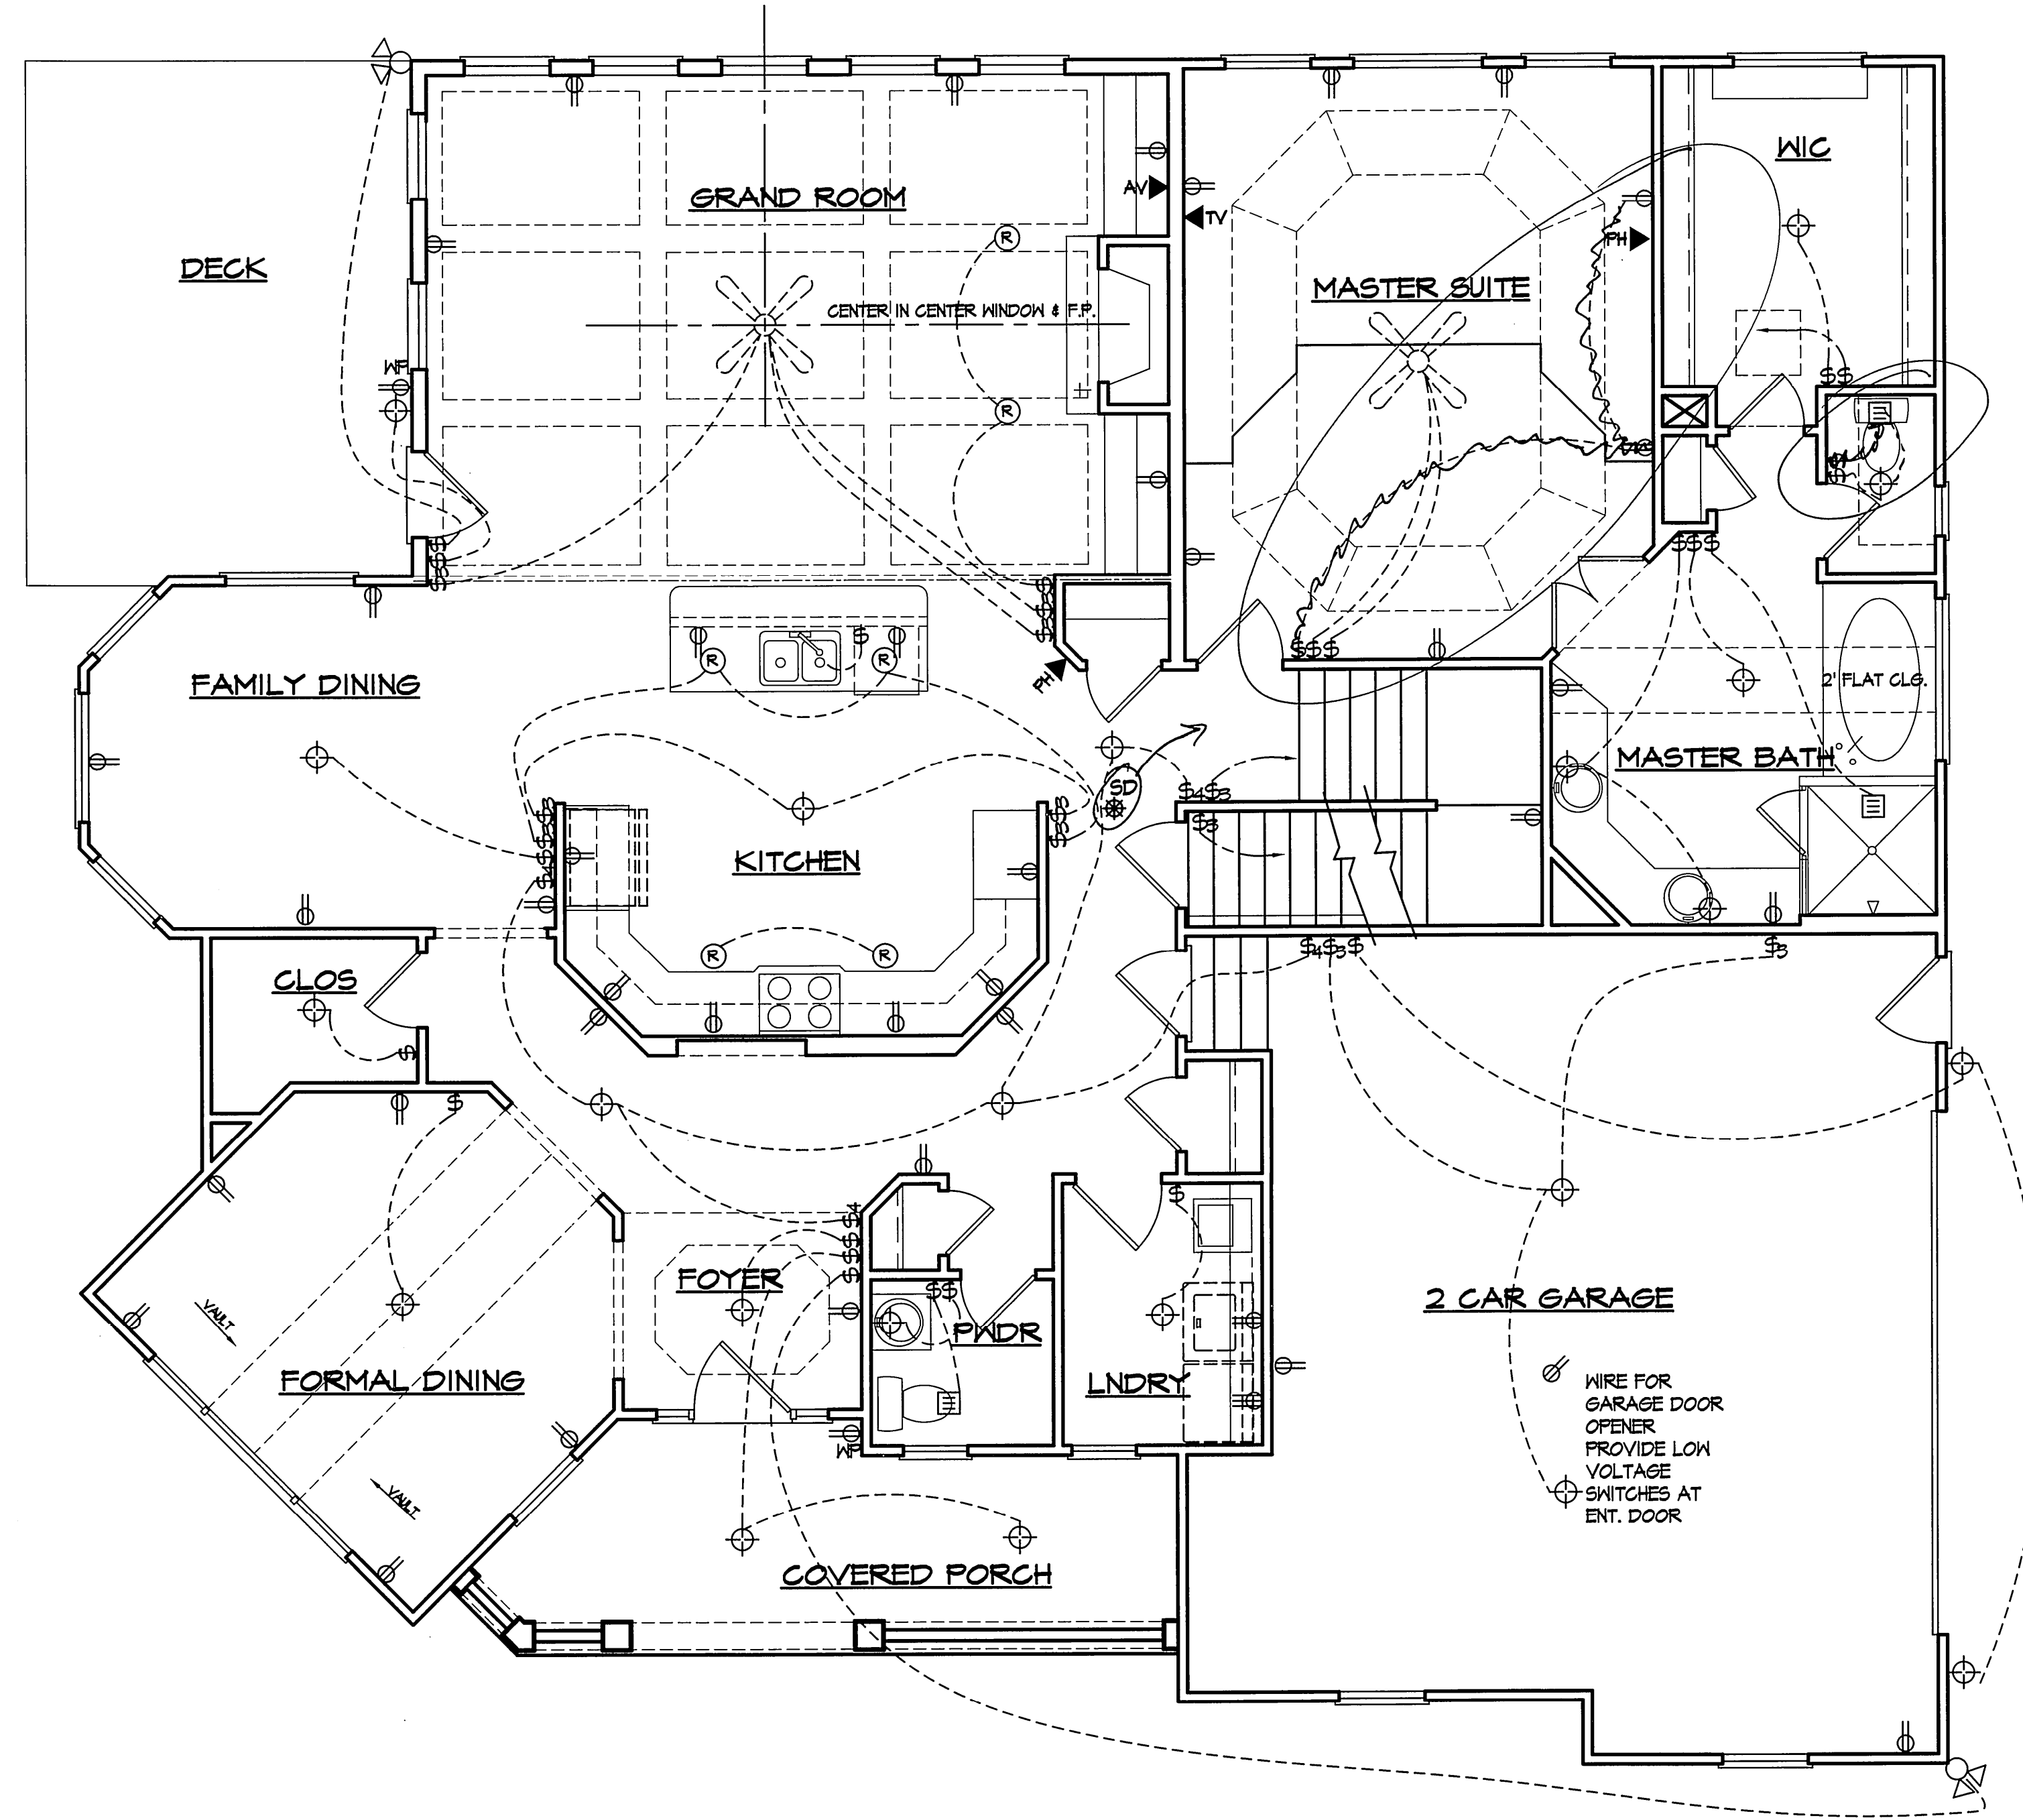

MAIN LEVEL ELECTRICAL PLAN
SCALE: 1/4" = 1'-0"

THE "BEECHWOOD"
FRONT ELEVATION & DETAILS

ORIGINAL DESIGN BY
STREET SCAPES
107 WEST COURTHOUSE SQUARE SUITE 210
CUMMING, GA 30040

Revision:	Date:

Comm. No. 0504
Dr. By: JKL
Date: 9/19/05
Sheet:

10a
2 CAR GARAGE

RELEASED FOR CONSTRUCTION